


1 SINGLE LINE DIAGRAM - DEMOLITION
E51 SCALE: NTS

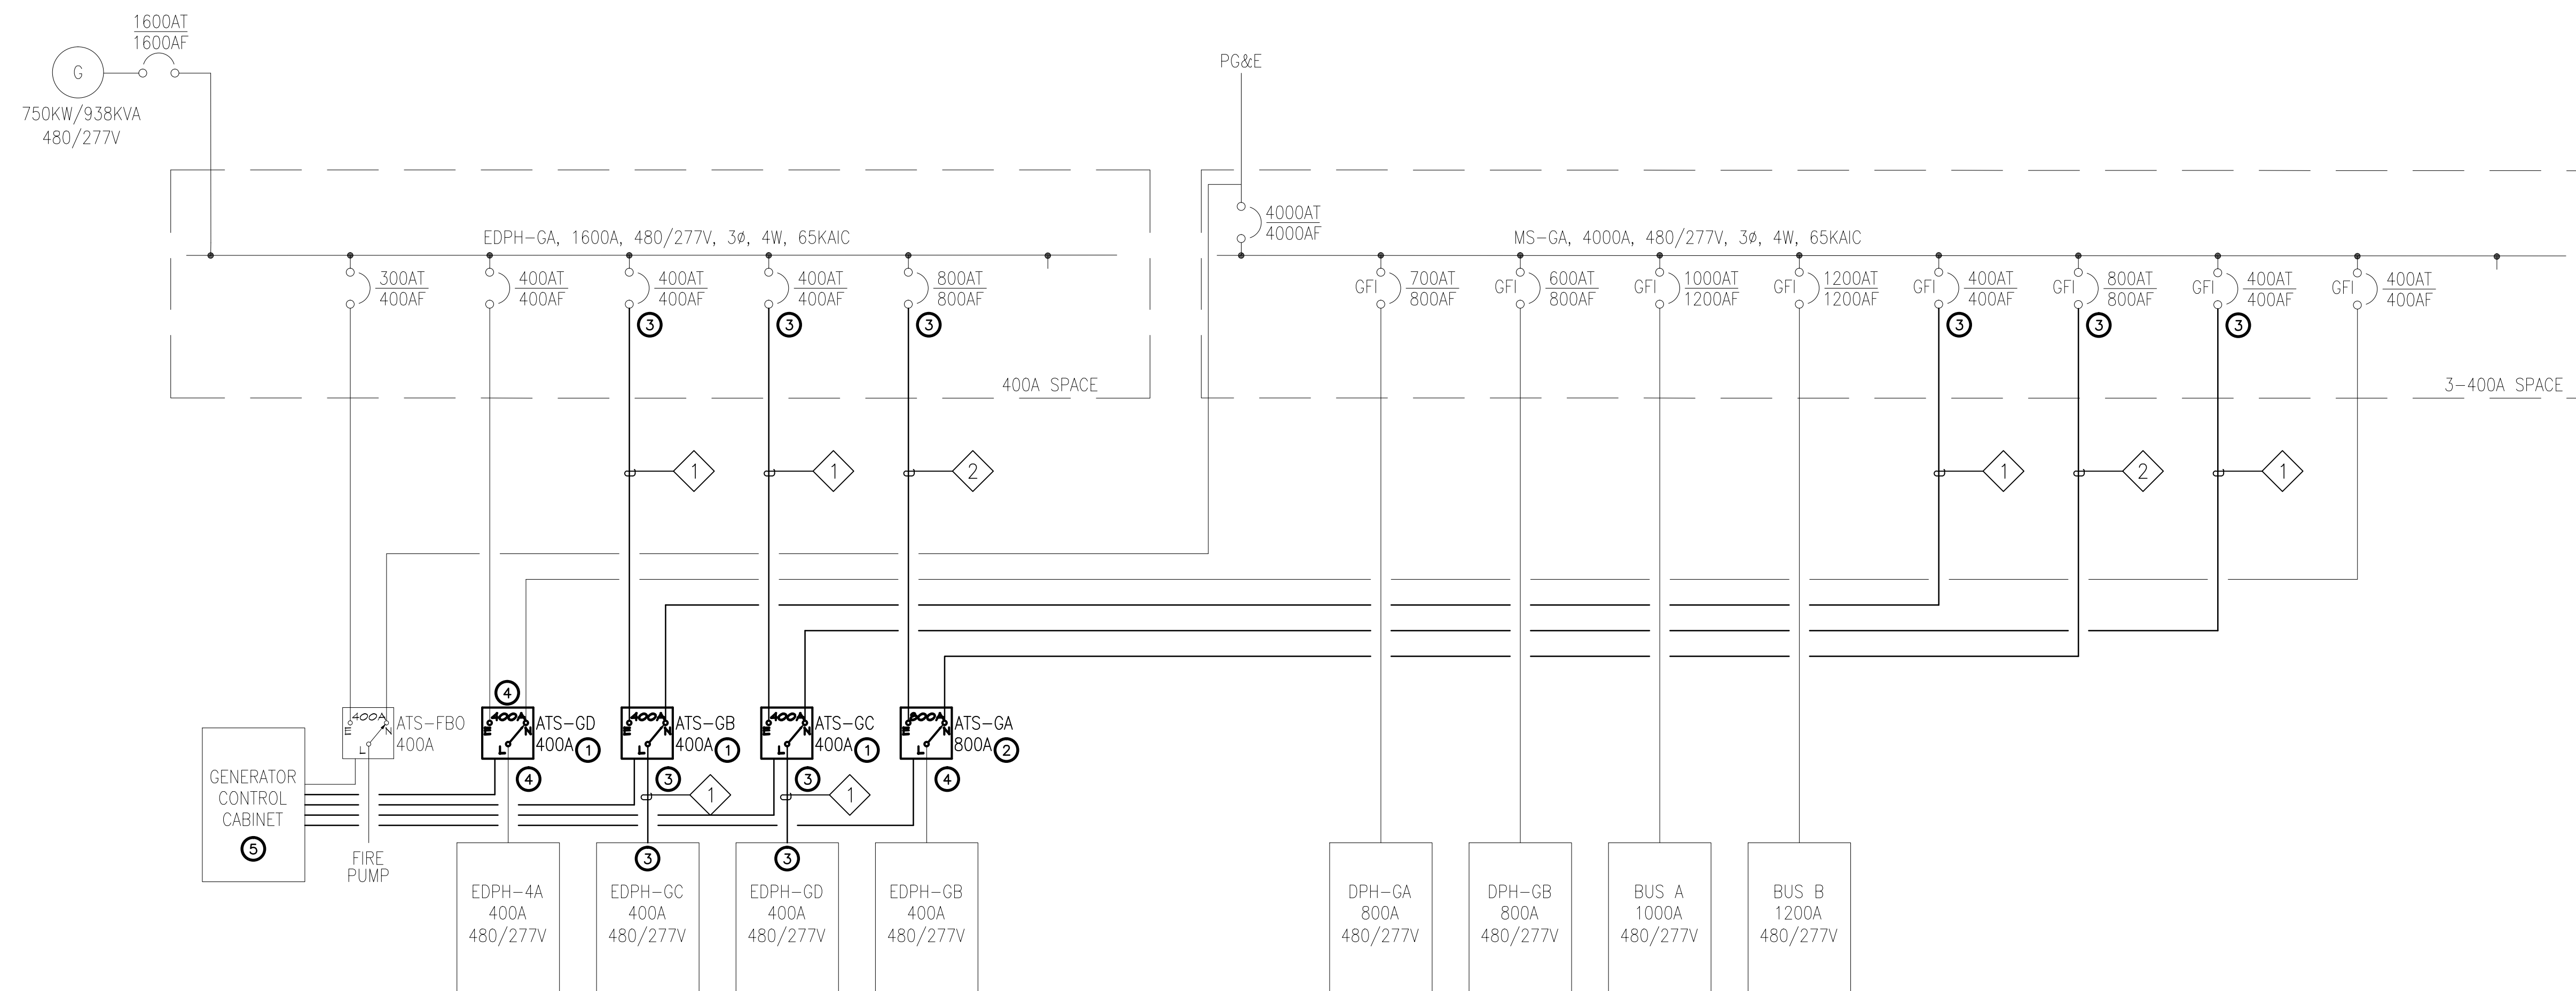

2 SINGLE LINE DIAGRAM - CONSTRUCTION
E51 SCALE: NTS